



TYPICAL TAXIWAY CONSTRUCTION

N.T.S.

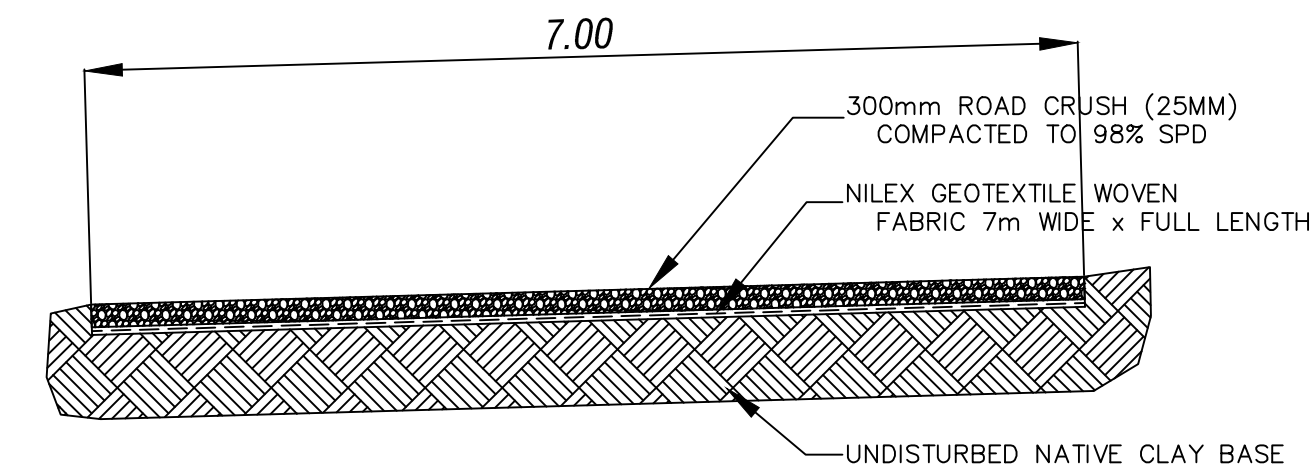



TYPICAL VEHICLE ACCESS ROUTE CONSTR.

N.T.S.

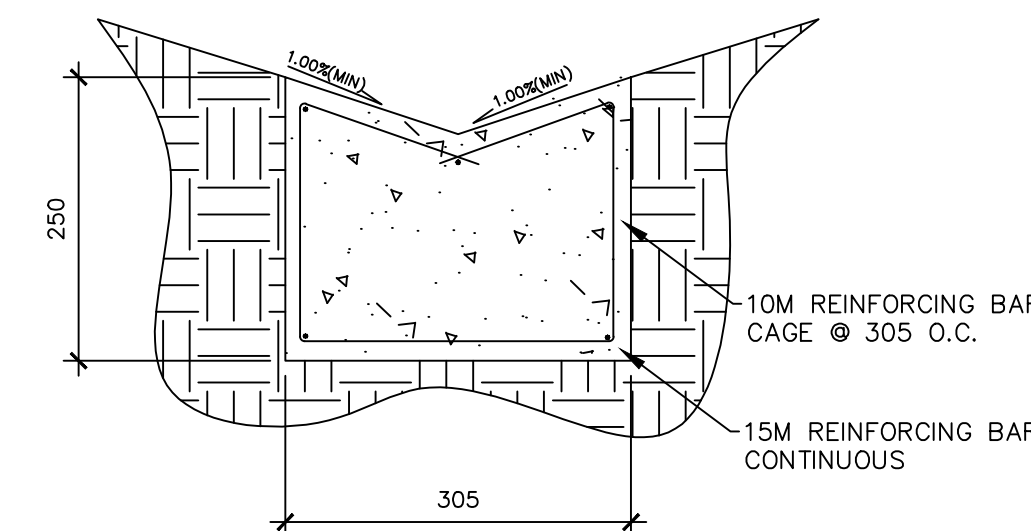

CONCRETE SWALE DETAIL

N.T.S.

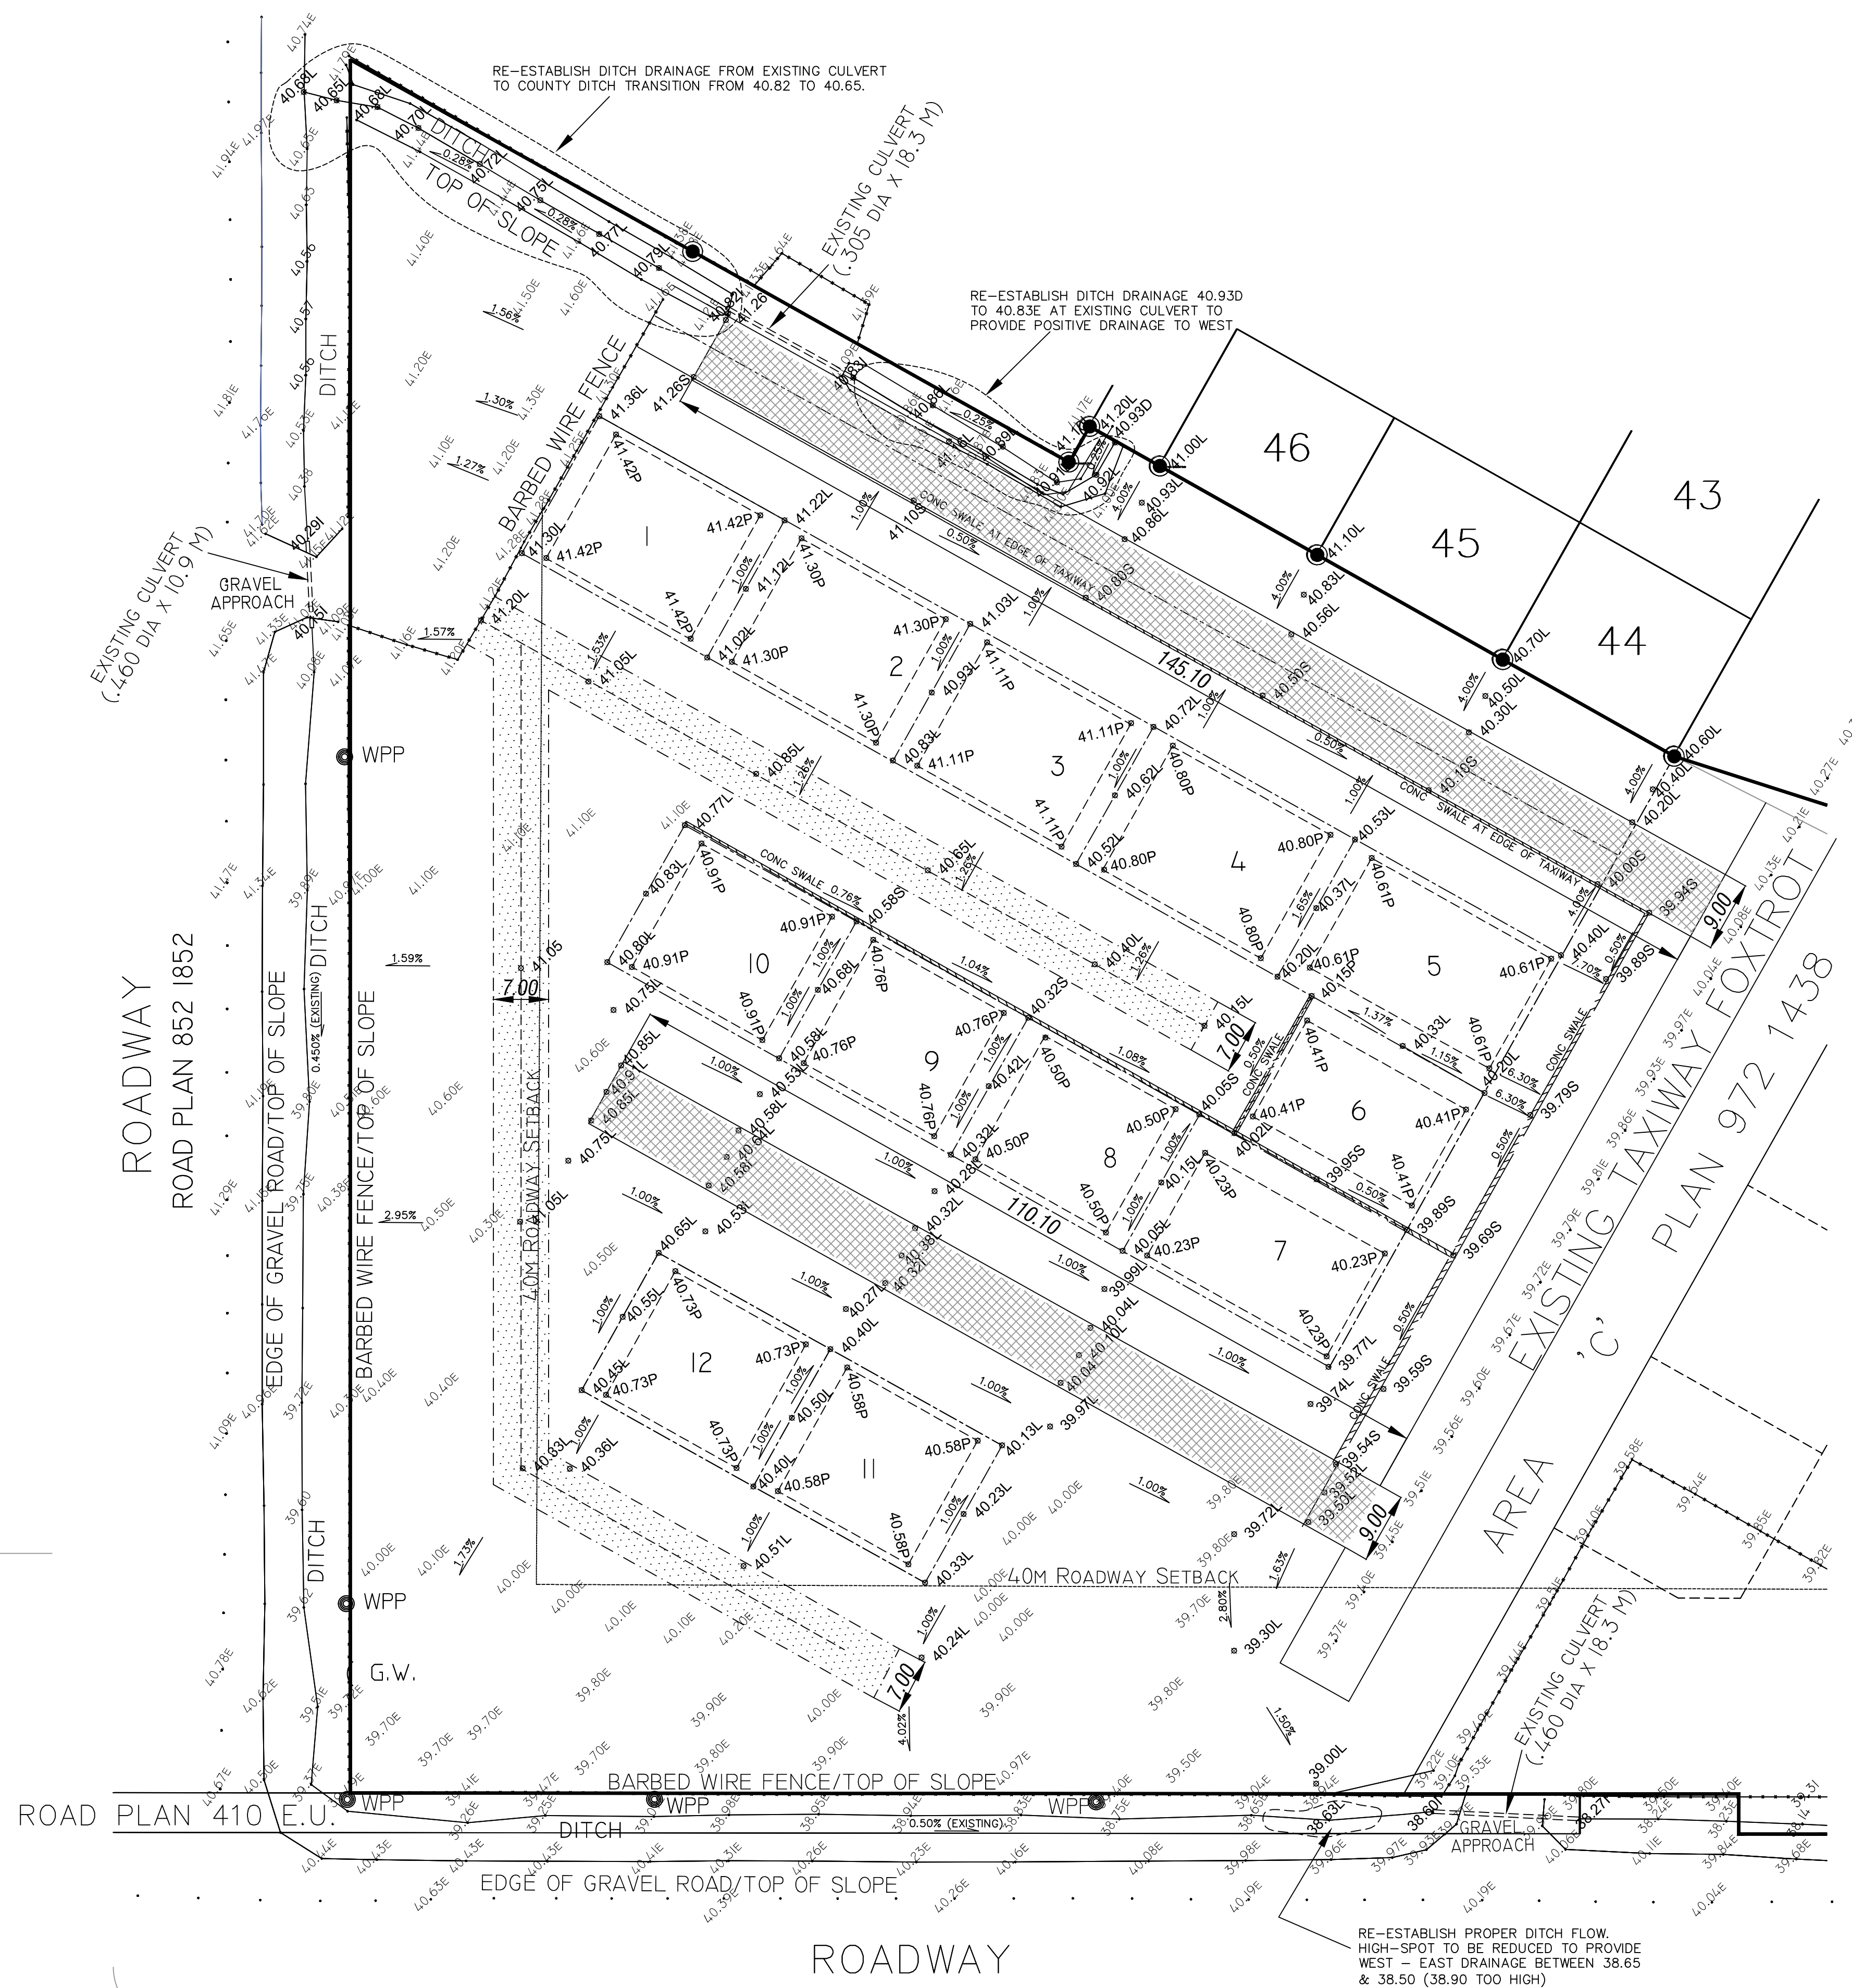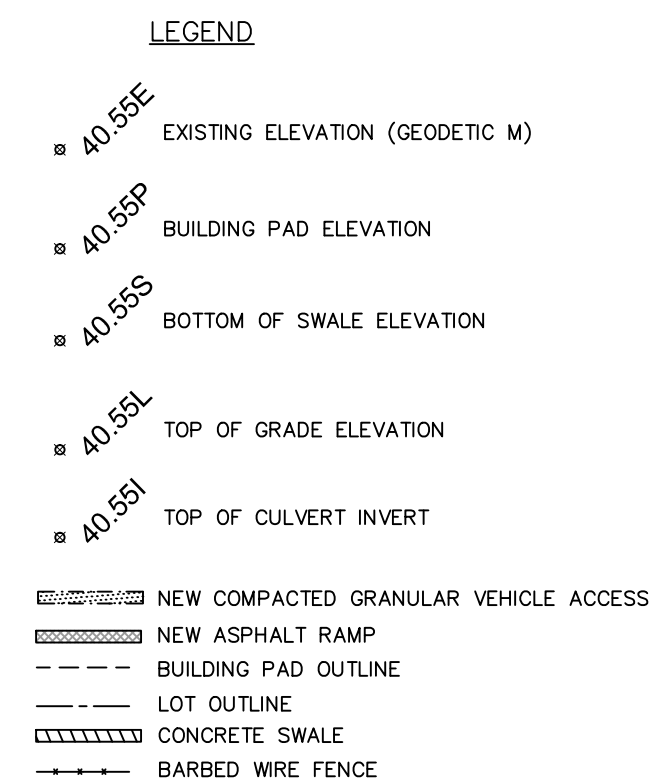

DRAINAGE PLAN PHASE 1

1: 500

 **SCL Engineering Ltd.**
Consulting Professional Engineers
#200 7205 Roper Road, Edmonton, Alberta
T6B 3J4 PH: (780) 440 6262 FAX: (780) 440 4371

Architechnics Ltd.

4909 - 75 Avenue
Edmonton, Alberta
T6B 2S3

(780)488-6969

Scale: 1: 500

Date: _____

Drawn By: KIWI

Checked By:

Project: **COOKING LAKE
AIRPORT**

Drawing:

DRAINAGE
PLAN
PHASE 1

Drawing No.
L-1

Rev. No. 